




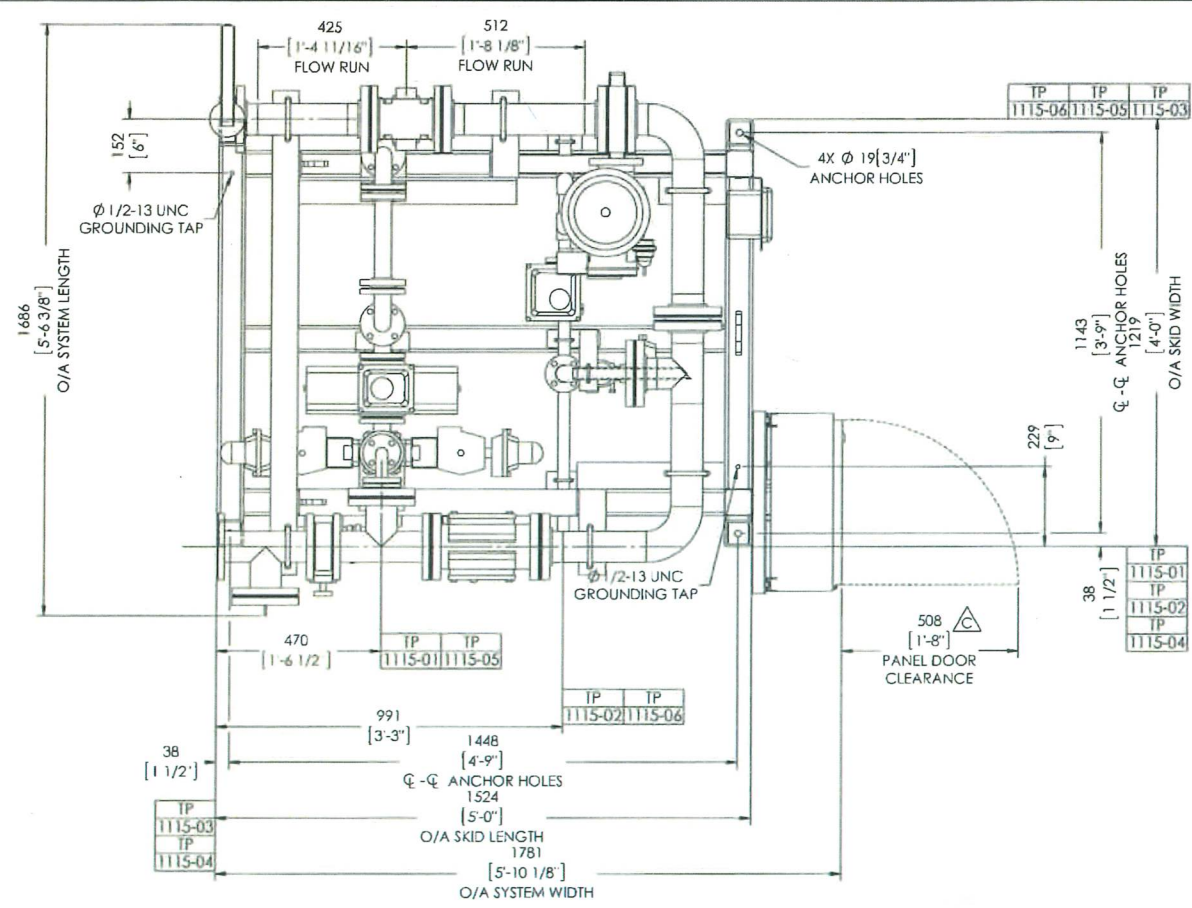


PLAN VIEW

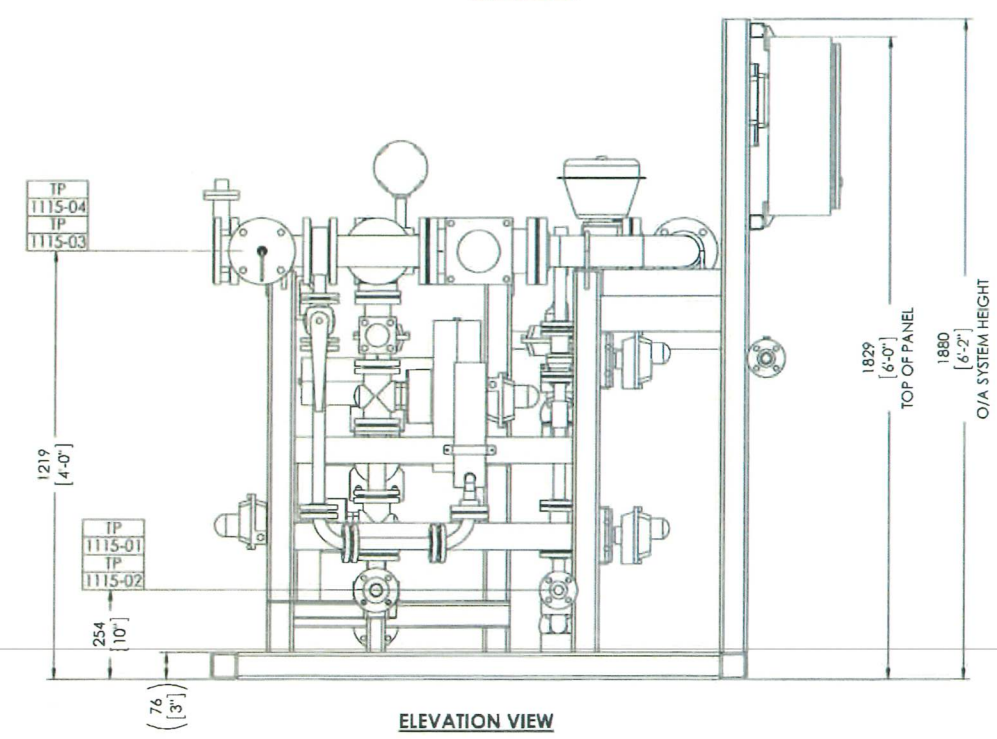


ELEVATION VIEW

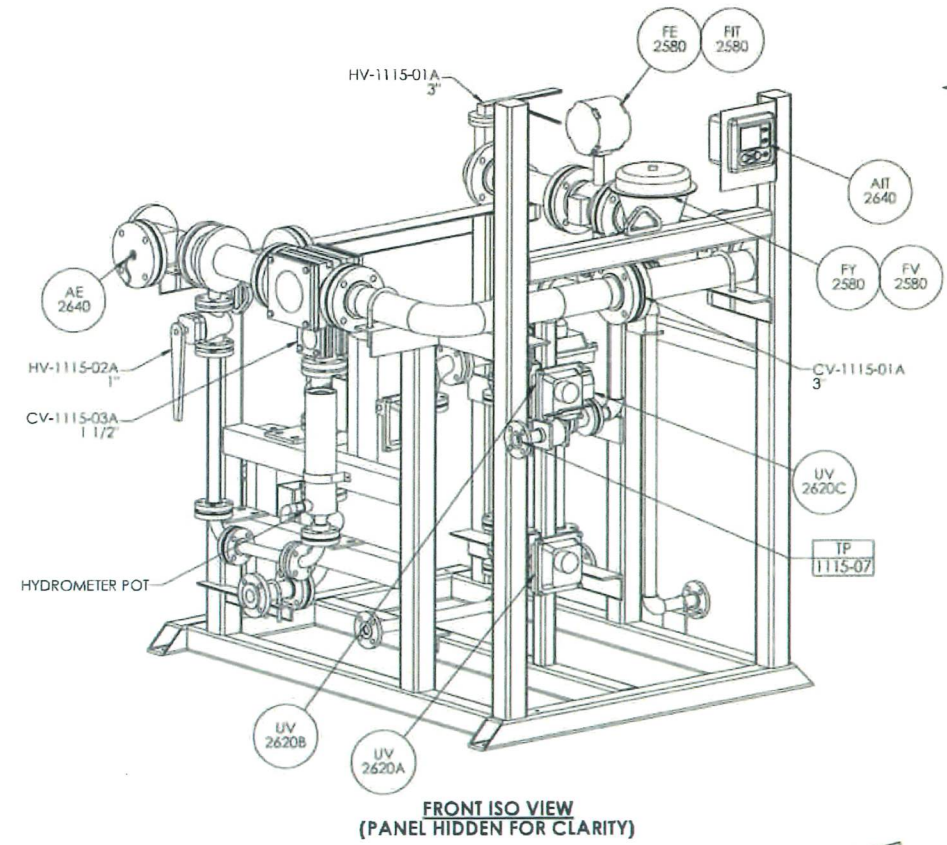

FRONT ISO VIEW
(PANEL HIDDEN FOR CLARITY)

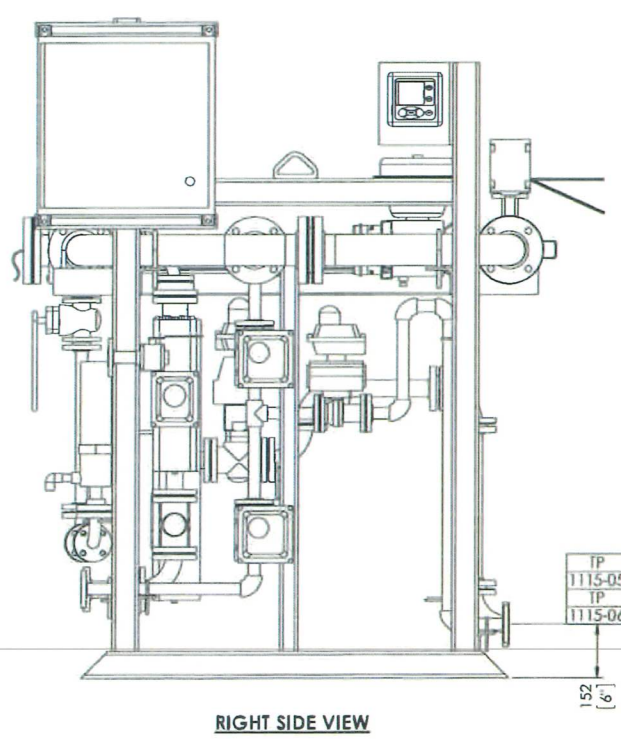

RIGHT SIDE VIEW

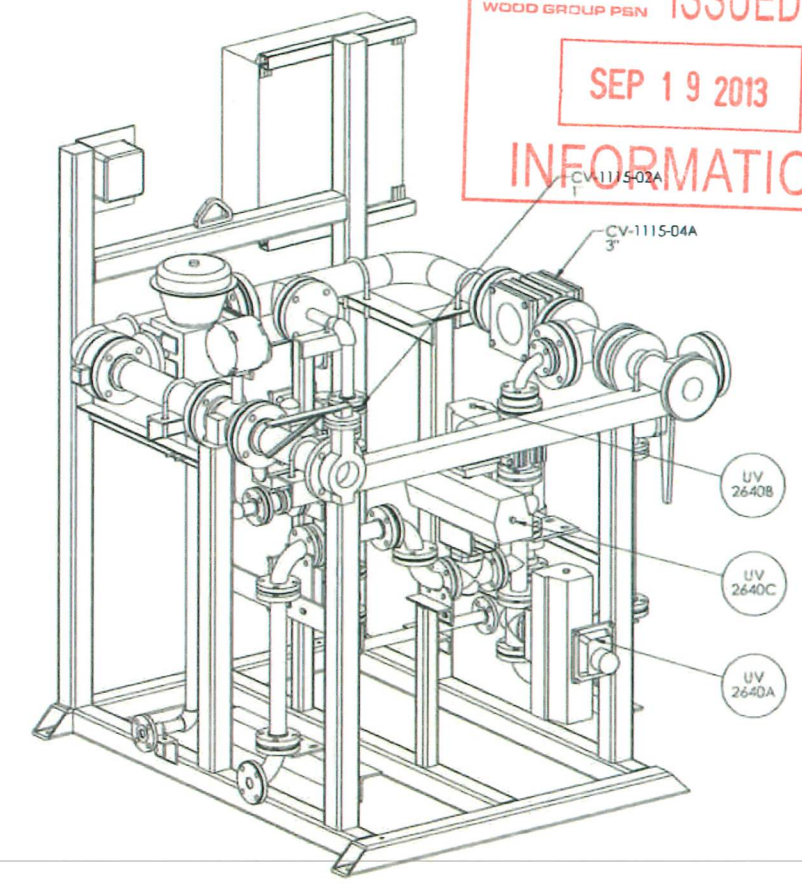

REAR ISO VIEW

ANDERSON TERMINATION POINT LIST			
TP No.	SIZE	RATING	DESCRIPTION
1115-01	1 1/2"	150# RF	ACID INLET FROM PUMP SKID
1115-02	1"	150# RF	CAUSTIC INLET FROM PUMP SKID
1115-03	3"	150# RF	DILUTION WATER INLET
1115-04	3"	150# RF	DILUTE CHEMICAL OUTLET
1115-05	1 1/2"	150# RF	ACID BLEED TO DRAIN
1115-06	1"	150# RF	CAUSTIC BLEED TO DRAIN
1115-07	1"	150# RF	INSTRUMENT AIR INLET

- NOTES:
1. DIMENSIONS LOCATING TERMINATION POINTS MAY VARY 9mm (±3/8").
 2. ALL PIPING WILL BE ASSEMBLED AND TESTED BY A.W.S.
 3. ALL BOLT HOLES TO STRADDLE MAJOR CENTER LINES.
 4. SHIPPING WEIGHT: 1,000 Kgs (2,200 Lbs)
OPERATING WEIGHT: 1,100 Kgs (2,420 Lbs)
 5. PAINT SPECIFICATION: PNT - 120128
 6. PIPE SPECIFICATION: PS - 120128-316SS/PTFE
 7. 6mm (1/4") CLEARANCE PROVIDED FOR ALL PIPE SUPPORTS.
 8. DIMENSIONS SHOWN IN PARENTHESIS (XX) ARE FOR REFERENCE ONLY.
 9. DIMENSIONS SHOWN qlyx dim e.g. 2X 3/8", ARE TYPICAL DIMENSIONS.
 10. UNLESS OTHERWISE NOTED, UNIT TO HAVE MINIMUM 1219mm (4'-0") CLEARANCE ALL AROUND FOR ACCESS.
 11. FOUNDATION LOADING CHART: DWG# 120128-0001-1-FL-001.

ISSUED FOR
SEP 19 2013
INFORMATION

THIS DRAWING, ALL INFORMATION AND KNOWLEDGE CONTAINED OR REFERRED HEREIN ARE THE CONFIDENTIAL AND PROPRIETARY PROPERTY OF ANDERSON WATER SYSTEMS. ANY AND ALL SUCH ARE INSTRUMENTS OF SERVICE FOR USE SOLELY WITH RESPECT TO THIS PROJECT. THESE INSTRUMENTS OF SERVICE SHALL NOT BE REPRODUCED, TRANSMITTED, DISCLOSED OR USED OTHERWISE IN WHOLE OR IN PART WITHOUT THE WRITTEN AUTHORIZATION OF ANDERSON WATER SYSTEMS.

REV	REVISION DESCRIPTION	DRAWN	CHECKED	APP	DATE
A	ORIGINAL ISSUE	MK	MG	DP	DEC 4 12
B	REVISED PER CUSTOMER COMMENTS	MK	MG	DP	JAN 7 13
C	REVISED PR CUSTOMER COMMENTS	MK	MG	DP	MAR 22 13

REV	REVISION DESCRIPTION	DRAWN	CHECKED	APP	DATE

PROJECT INFORMATION
ZARGON LITTLE BOW ASP FACILITY
LSD 16-31-14-18 W4M
CONTRACT NUMBER:
120128

ANDERSON WATER SYSTEMS
1295 CORMORANT RD, SUITE 200
Ancaster, Ontario
L9G 4V5 Canada
Phone: +1 (289) 346-1000
www.AWSL.com

BY	DATE
DRAWN MK	DEC 4 12
CHECKED MG	DEC 4 12
APP DP	DEC 4 12

WEAK ACID CATION
DILUTION SKID
GENERAL ARRANGEMENT
REF: 120128-0001-1-PID-003
SCALE NTS
SHEET 1 OF 1
D 120128-1115-1-GA-001
C